 


PROPOSED FALSE CEILING LAYOUT PLAN

ARMSTRONG FALSE CEILING SHOWN THUS BY

GYPSUM BOARD FALSE CEILING SHOWN THUS BY



Project : PROPOSED INTERIOR LAYOUT PLAN FOR INDIAN BANK AT S.P. MARG BRANCH CIVIL LINE PRAYAGRAJ

Zone: PRAYAGRAJ U.P.

DRAWING TITLE: PROPOSED FALSE CEILING LAYOUT PLAN

DATE: 20-08-2024

SCALE:


DRAWING NO. - 06

CONSULTANT :- ARCONS


AR. AKHILESHWAR SINGH

OFF: LOTUS APARTMENT, TASHKAND MARG, CIVIL LINES, ALLD.


TEL: +91-9415214329

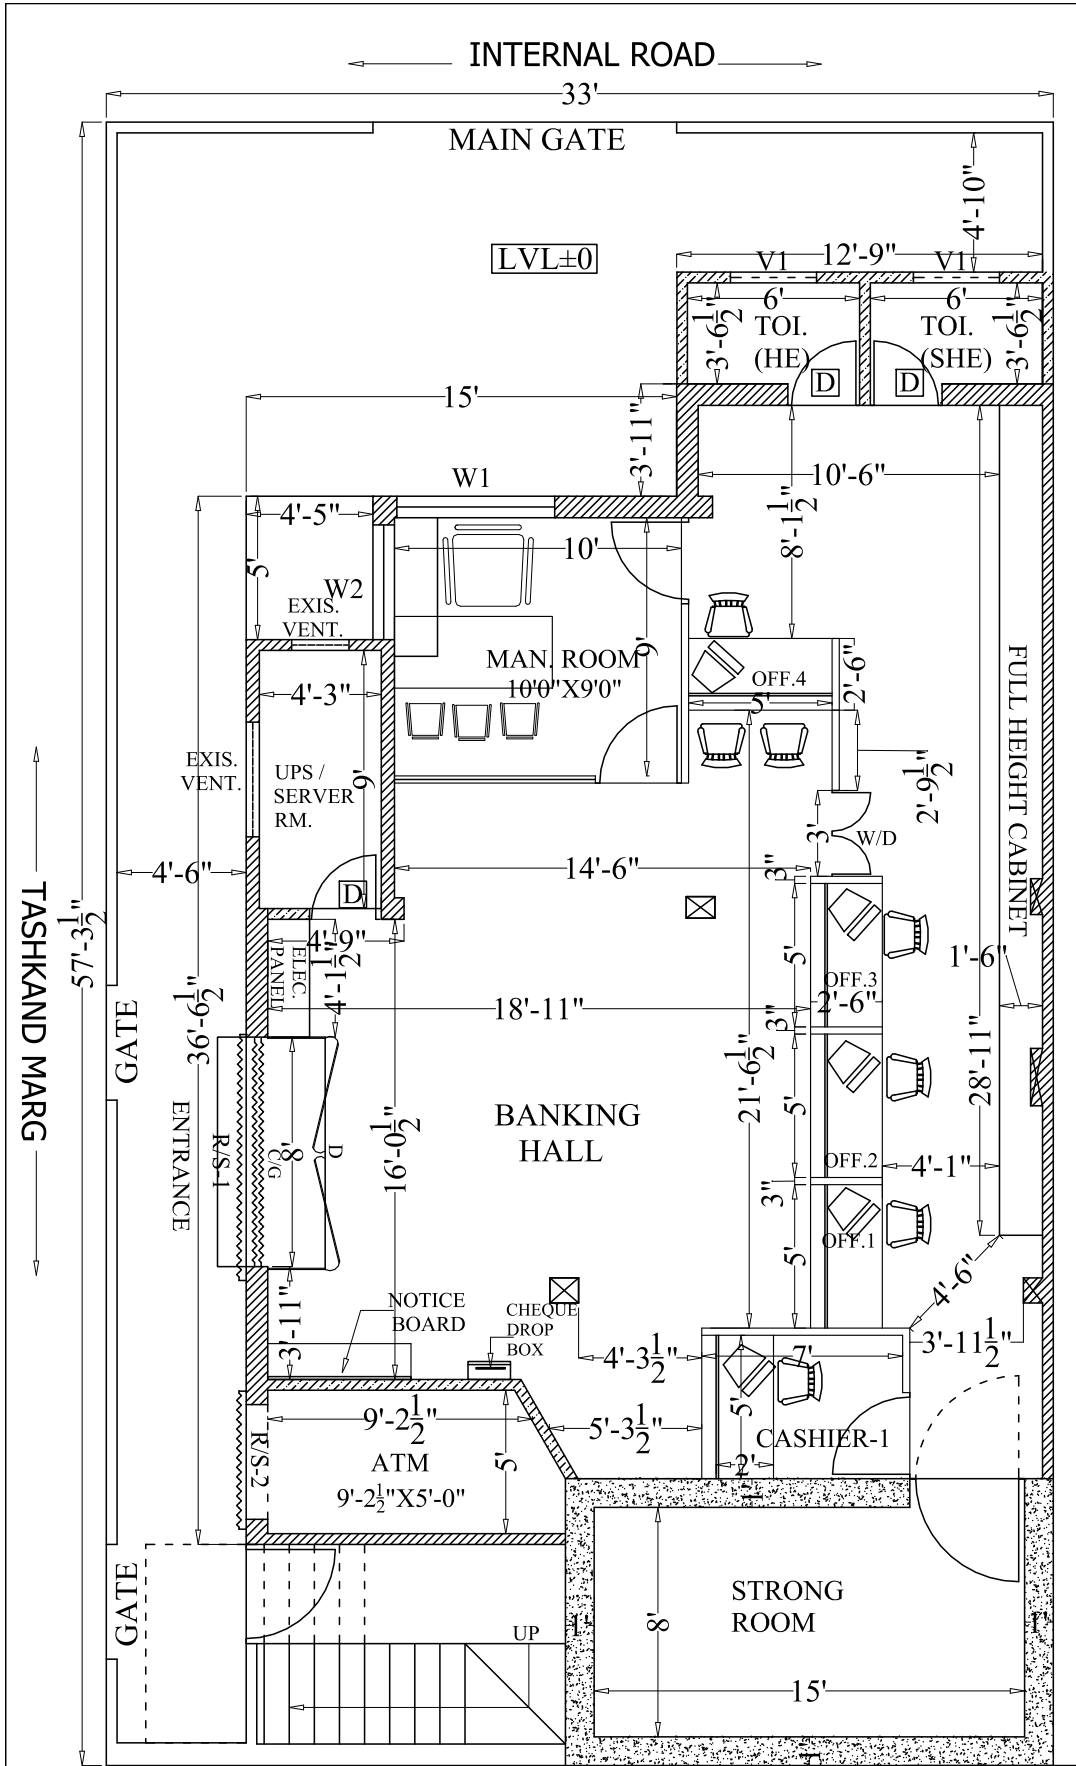

PROPOSED INTERIOR LAYOUT PLAN

 


Project : PROPOSED INTERIOR LAYOUT PLAN FOR INDIAN BANK AT S.P. MARG BRANCH CIVIL LINE PRAYAGRAJ	DRAWING TITLE: INTERIOR LAYOUT PLAN		CONSULTANT :- ARCONS AR. AKHILESHWAR SINGH OFF: LOTUS APARTMENT, TASHKAND MARG, CIVIL LINES, ALLD. TEL: +91-9415214329
	DATE 03-08-2024	SCALE	
Zone: PRAYGRAJ U.P.	DRAWING NO.- 04		

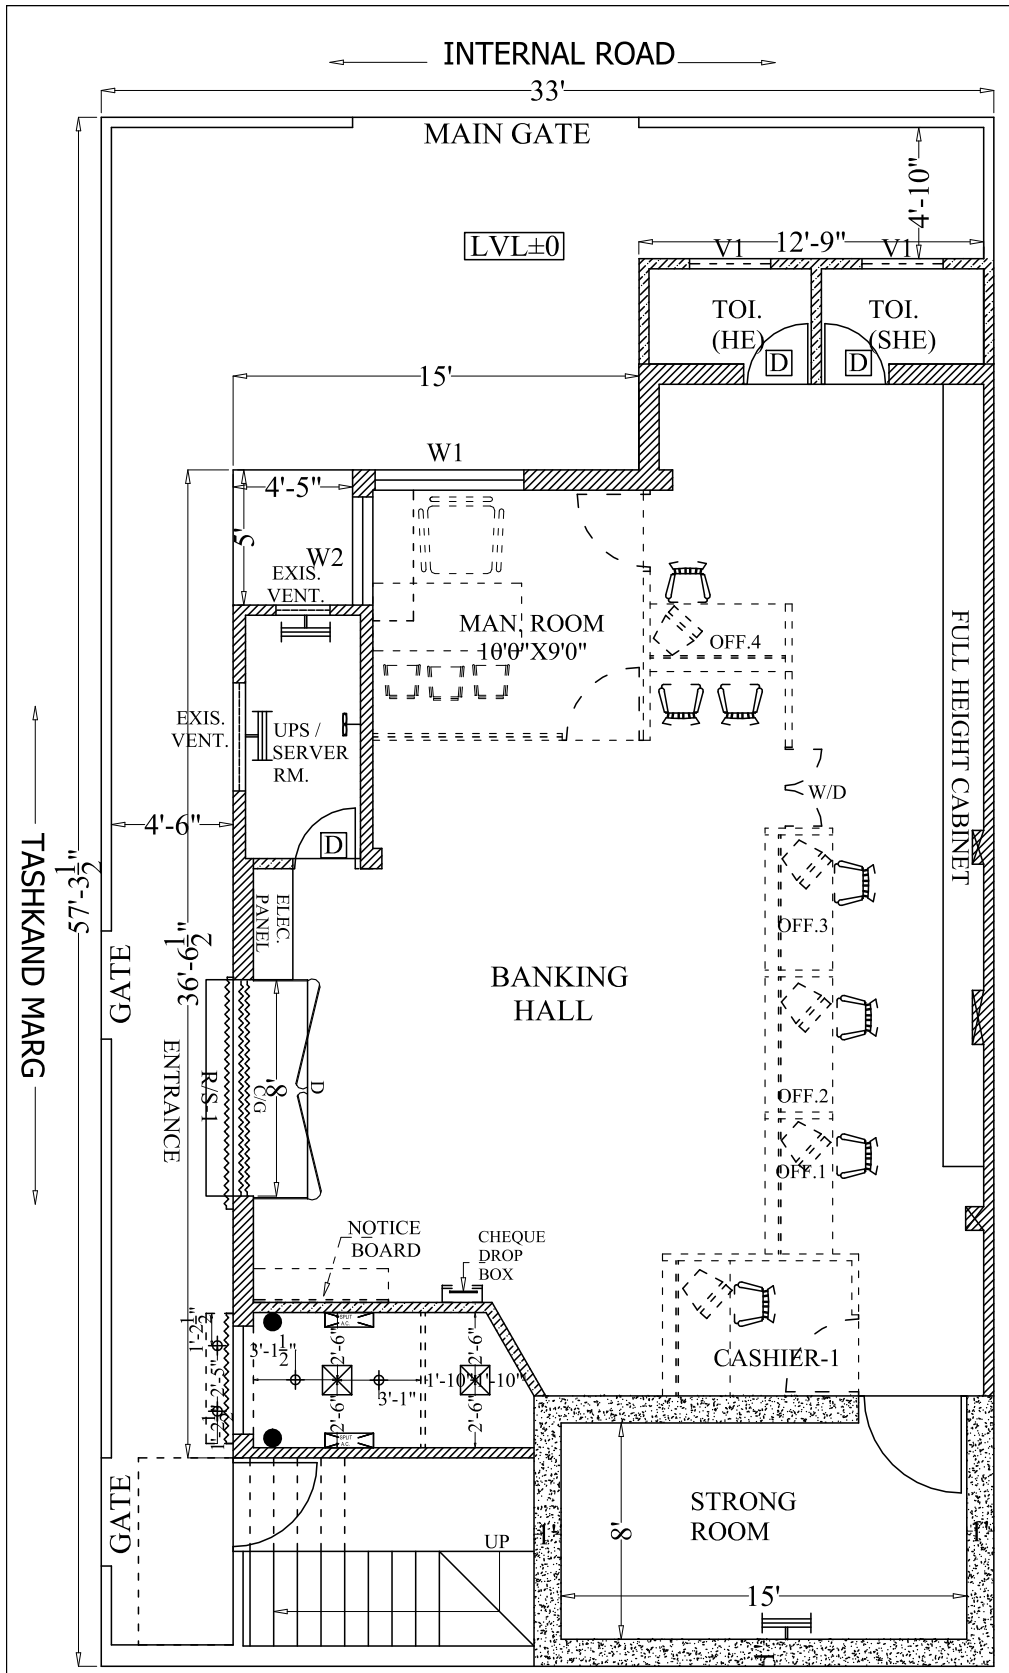


LEGEND		NO.
●	(A.C. POINT)	02
⊠	2'X2' LED PANEL	02
⊕	LED DOWN LIGHTER 18 WATT	04

●	(A.C. POINT)	02
⊠	2'X2' LED PANEL	02
⊕	LED DOWN LIGHTER 18 WATT	04

 


PROPOSED ELECTRICAL LAYOUT PLAN FOR ATM

Project : PROPOSED INTERIOR LAYOUT PLAN FOR INDIAN BANK AT S.P. MARG BRANCH CIVIL LINE PRAYAGRAJ	DRAWING TITLE: PROPOSED ELECTRICAL LAYOUT PLAN FOR ATM DATE 28-08-2024	CONSULTANT : - ARCONS AR. AKHILESHWAR SINGH OFF: LOTUS APARTMENT, TASHKAND MARG, CIVIL LINES, ALLD. TEL: +91-9415214329
Zone: PRAYGRAJ U.P.	SCALE	DRAWING NO. - 7

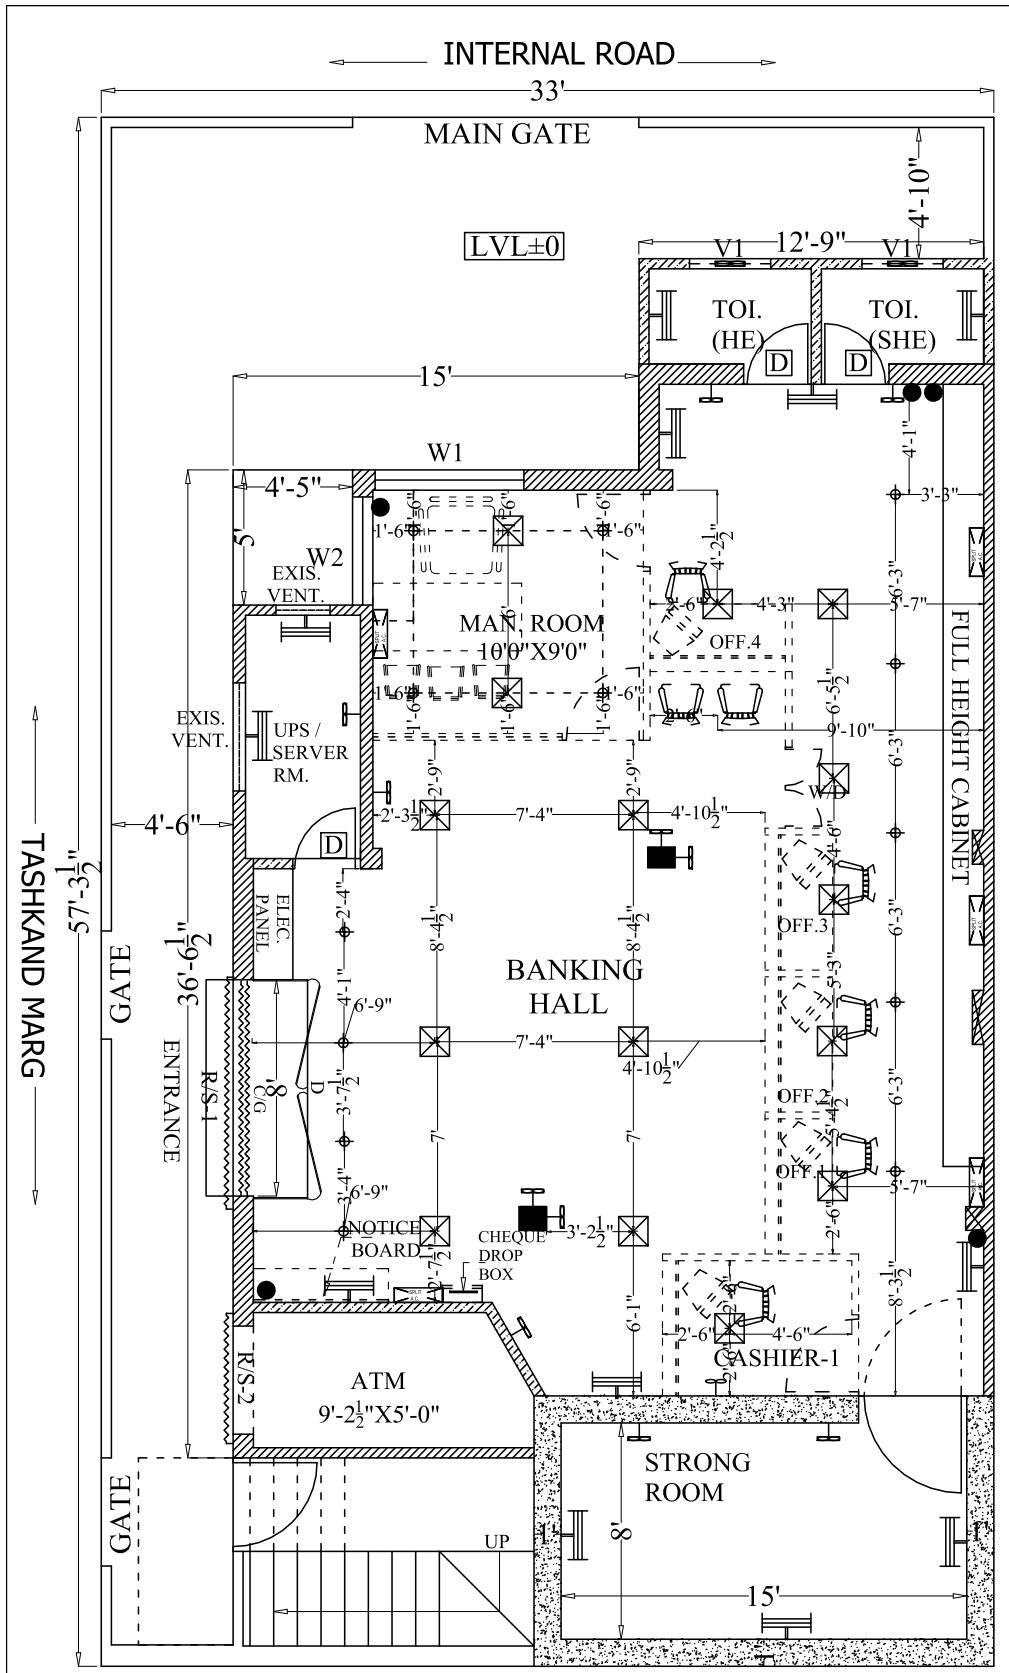

LEGEND		NO.
	WALL FAN 300MM	01
	2'X2' LED PANEL	15
	LED PANEL 1.5 WATT	12

	20W LED PATTI	10
	(A.C. POINT)	05
	WALL BRACKET FAN 450MM METAL BODY	11
	300MM EXHAUST FAN	02

 

PROPOSED ELECTRICAL LAYOUT PLAN FOR BANK

Project : PROPOSED INTERIOR LAYOUT PLAN FOR INDIAN BANK AT S.P. MARG BRANCH CIVIL LINE PRAYAGRAJ	DRAWING TITLE: PROPOSED ELECTRICAL LAYOUT PLAN FOR BANK DATE 20-08-2024	CONSULTANT : - ARCONS AR. AKHILESHWAR SINGH OFF.: LOTUS APARTMENT, TASHKAND MARG, CIVIL LINES, ALLD. TEL: +91-9415214329
Zone: PRAYAGRAJ U.P.	SCALE	DRAWING NO. - 05