

SN.	DESCRIPTIONS	SYM	HGT
1.	WALL FAN		6'-6"
2.	CEILING LIGHT (2X18W)		CEILING
3.	CEILING LIGHT (1X18W)		CEILING
4.	EXHAUST FAN(CEILING)		CEILING
5.	SWITCH BOARD		4'-0"
6.	15A POWER POINT		4'-0"
7.	SDB		4'-0"
8.	PDB		4'-0"
9.	COMPUTER POINT		SEE BELOW
10.	TELEPHONE POINT		SEE BELOW
11.	2NOS. 5A SOCKET WITH 15A SWITCH		SEE BELOW
12.	RAW POWER		SEE BELOW
13.	5A SOCKET		3'-6"
14.	AC POINT		7'-0"
15.	UPSDB		4'-0"
16.	15A SOCKET		3'-6"
17.	WALL BRACKET		7'-0"
18.	2x36W CEILING LIGHT		CEILING

- 3 NOS 5 A SOCKET (150 MM BELOW DESK TOP) WITH 15A SWITCH (150 MM ABOVE DESK TOP)
- 5 A SWITCH SOCKET FOR RAW (150 MM ABOVE DESK TOP)
- 1 NO. DATA (150MM BELOW DESK TOP)
- 1NO. VOICE (150MM ABOVE DESK TOP)
- 15 A SWITCH SOCKET FOR RAW (150 MM BELOW DESK TOP)

DESCRIPTIONS	SYM	HGT
WALL FAN		6'-6"
TUBE LIGHT (LED)		8'-0" / ceiling
2'-0" X 2'-0" LIGHT (LED)		ceiling
CEILING FAN		ceiling
15 W DOWN LIGHTER (LED)		ceiling
AC POINTS		7'-0"
EXHAUST FAN		7'-0"
CASSETTE AC		ceiling

	2'X2' GRID CEILING	GRID CEILING
	2'X2' 36 WT GRID LIGHT	ON CEILING
	18W BLAIRE RECESSED LED DOWN LIGHT.	ON CEILING
	18W LIGHT UP DOWN LINEAR RECESSED LED LIGHT	ON CEILING

PROJECT NAME:
PROPOSED INTERIOR FURNISHING LAYOUT FOR INDIAN BANK TIKAMGARH BRANCH (M.P)

CLIENT NAME & ADDRESS :



Indian Bank

Zonal Office, Satna
Jai Stambh Chowk, 2nd floor, Satna
485001 (M.P)


CONSULTANTS NAME & ADDRESS :



Vaastu Vikalp Architects

Rarwarbegpur, Post Kanakpur, Near Pindra Railway Station, Varanasi-210655
Ph:9899328602, 9997591118, vva.global@gmail.com

ARCHITECT: Ar. Rahul Chaudhary

NORTH: 

DRAWING TITLE : ELECTRICAL - A.C LOCATION LAYOUT PLAN

SHEET No: 1 / 1

DEALT : Er. Sanjay Verma

CHECKED : Ar. Manoj Kumar


SCALE : 1:60

DATE : 02Dec. 2024

DRAWING NO. : WA/BANK/INDB/TKMGRH/LP

OPTION/ REVISION : OP-00/R-00

ELECTRICAL - A.C LOCATION LAYOUT PLAN

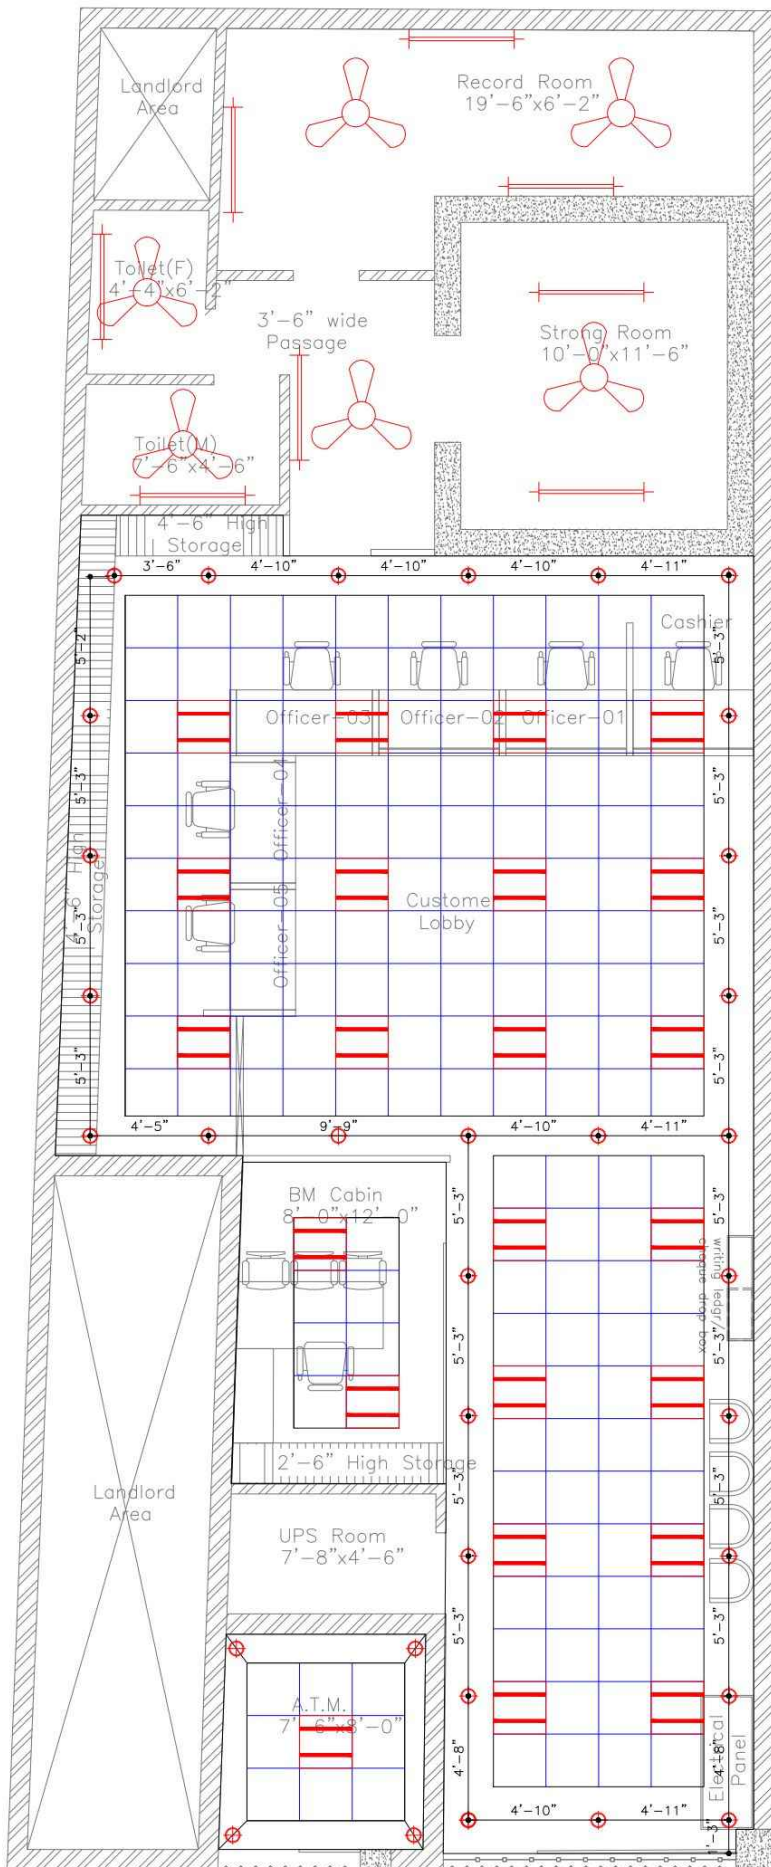

ELECTRICAL LEGENDS

SN.	DESCRIPTIONS	SYM	HGT
1.	WALL FAN		6'-6"
2.	CEILING LIGHT (2X18W)		CEILING
3.	CEILING LIGHT (1X18W)		CEILING
4.	EXHAUST FAN(CEILING)		CEILING
5.	SWITCH BOARD		4'-0"
6.	15A POWER POINT		1'-0"
7.	SDB		4'-0"
8.	PDB		4'-0"
9.	COMPUTER POINT		SEE BELOW
10.	TELEPHONE POINT		SEE BELOW
11.	2NOS. 5A SOCKET WITH 15A SWITCH		SEE BELOW
12.	RAW POWER		SEE BELOW
13.	5A SOCKET		3'-6"
14.	AC POINT		7'-0"
15.	UPSDB		4'-0"
16.	15A SOCKET		3'-6"
17.	WALL BRACKET		7'-0"
18.	2x36W CEILING LIGHT		CEILING

- 3 NOS 5 A SOCKET (150 MM BELOW DESK TOP) WITH 15A SWITCH (150 MM ABOVE DESK TOP)
- 5 A SWITCH SOCKET FOR RAW (150 MM ABOVE DESK TOP)
- 1 NO. DATA (150MM BELOW DESK TOP)
- 1NO. VOICE (150MM ABOVE DESK TOP)
- 15 A SWITCH SOCKET FOR RAW (150 MM BELOW DESK TOP)

ELECTRICAL LEGENDS

DESCRIPTIONS	SYM	HGT
WALL FAN		6'-6"
TUBE LIGHT (LED)		8'-0"/ ceiling
2'-0" X 2'-0" LIGHT (LED)		ceiling
CEILING FAN		ceiling
15 W DOWN LIGHTER (LED)		ceiling
AC POINTS		7'-0"
EXHAUST FAN		7'-0"
CASSETTE AC		ceiling

	2X2' GRID CEILING	GRID CEILING
	2X2' 36 WT GRID LIGHT	ON CEILING
	18W BLAIRE RECESSED LED DOWN LIGHT.	ON CEILING
	18W LIGHT UP DOWN LINEAR RECESSED LED LIGHT	ON CEILING

PROJECT NAME:

PROPOSED INTERIOR FURNISHING LAYOUT FOR INDIAN BANK TIKAMGARH BRANCH (M.P)

CLIENT NAME & ADDRESS :



 
Zonal Office, Satna
Jai Stambh Chowk, 2nd floor, Satna
485001 (M.P)

CONSULTANTS NAME & ADDRESS :



Rarwarbegpur, Post Kanakpur, Near Pindra Railway Station, Varanasi-210655
Ph:9899328602, 9997591118,
vva.global@gmail.com

ARCHITECT:
Ar. Rahul Chaudhary




DRAWING TITLE :
ELECTRICAL - LIGHT LOCATION
LAYOUT PLAN

SHEET No
1
1

DEALT : Er. Sanjay Verma
CHECKED : Ar. Manoj Kumar

SCALE : 1:60
DATE : 02Dec. 2024

DRAWING NO. : VA/BANK/INDB/TKMGRH/LP
OPTION/ REVISION
0P-00/R-00

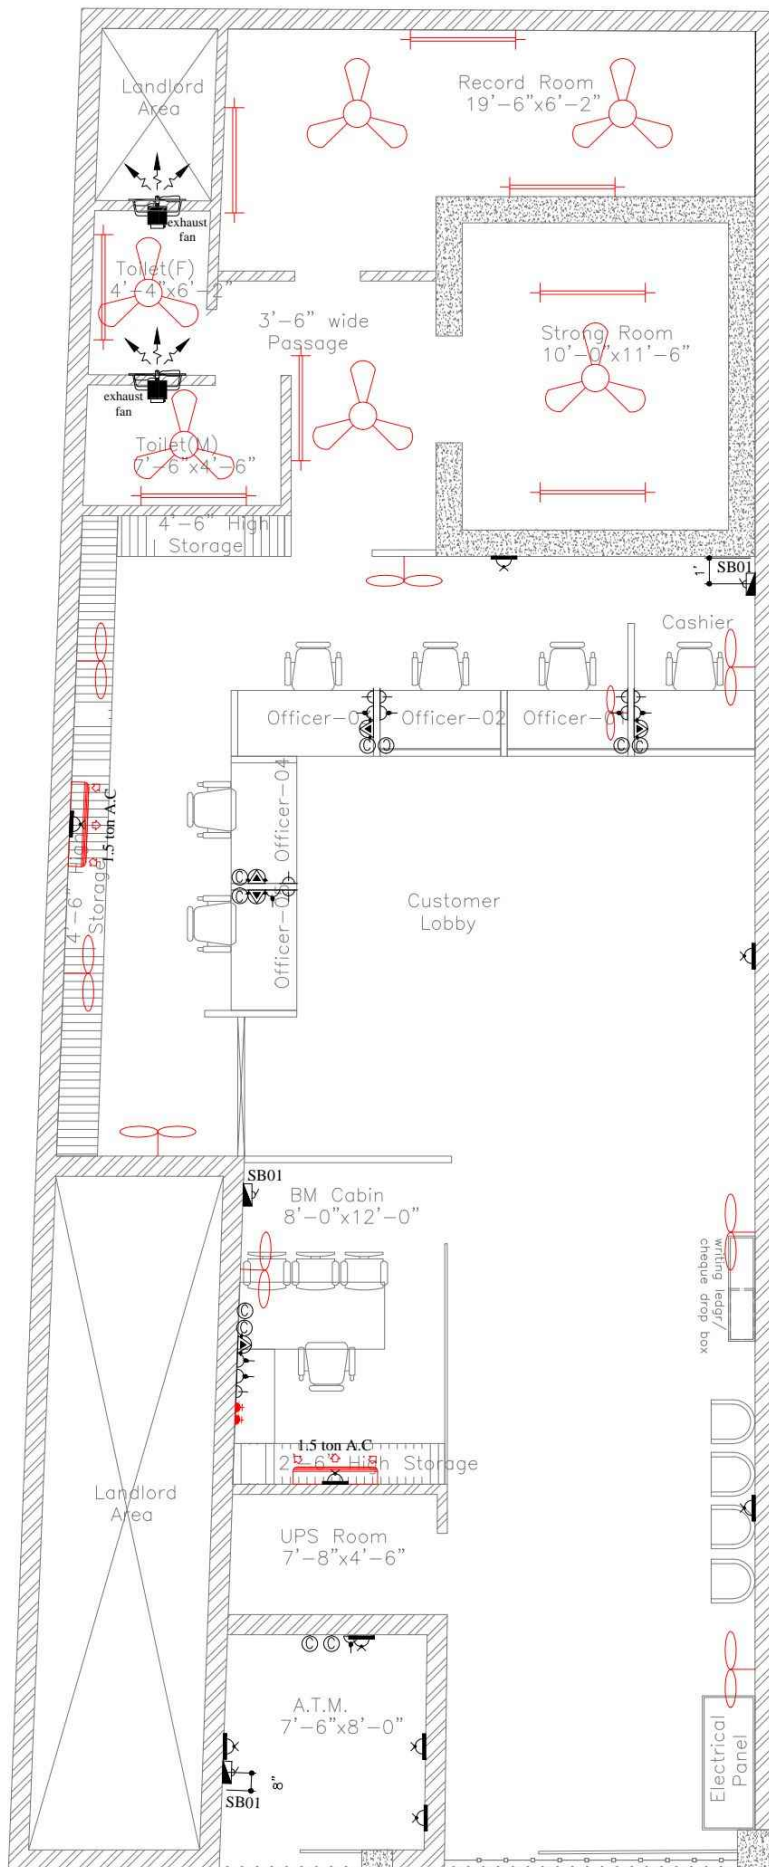

ELECTRICAL LEGENDS

SN.	DESCRIPTIONS	SYM	HGT
1.	WALL FAN		6'-6"
2.	CEILING LIGHT (2X18W)		CEILING
3.	CEILING LIGHT (1X18W)		CEILING
4.	EXHAUST FAN(CEILING)		CEILING
5.	SWITCH BOARD		4'-0"
6.	15A POWER POINT		1'-0"
7.	SDB		4'-0"
8.	PDB		4'-0"
9.	COMPUTER POINT		SEE BELOW
10.	TELEPHONE POINT		SEE BELOW
11.	2NOS. 5A SOCKET WITH 15A SWITCH		SEE BELOW
12.	RAW POWER		SEE BELOW
13.	5A SOCKET		3'-6"
14.	AC POINT		7'-0"
15.	UPSDB		4'-0"
16.	15A SOCKET		3'-6"
17.	WALL BRACKET		7'-0"
18.	2x36W CEILING LIGHT		CEILING

- 3 NOS 5 A SOCKET (150 MM BELOW DESK TOP) WITH 15A SWITCH (150 MM ABOVE DESK TOP)
- 5 A SWITCH SOCKET FOR RAW (150 MM ABOVE DESK TOP)
- 1 NO. DATA (150MM BELOW DESK TOP)
- 1NO. VOICE (150MM ABOVE DESK TOP)
- 15 A SWITCH SOCKET FOR RAW (150 MM BELOW DESK TOP)

ELECTRICAL LEGENDS

DESCRIPTIONS	SYM	HGT
WALL FAN		6'-6"
TUBE LIGHT (LED)		8'-0"/ ceiling
2'-0" X 2'-0" LIGHT (LED)		ceiling
CEILING FAN		ceiling
15 W DOWN LIGHTER (LED)		ceiling
AC POINTS		7'-0"
EXHAUST FAN		7'-0"
CASSETTE AC		ceiling

	2X2' GRID CEILING	GRID CEILING
	2X2' 36 WT GRID LIGHT	ON CEILING
	18W BLAIRE RECESSED LED DOWN LIGHT.	ON CEILING
	18W LIGHT UP DOWN LINEAR RECESSED LED LIGHT	ON CEILING

PROJECT NAME:
PROPOSED INTERIOR FURNISHING LAYOUT FOR INDIAN BANK TIKAMGARH BRANCH (M.P)

CLIENT NAME & ADDRESS :

Zonal Office, Satna
Jai Stambh Chowk, 2nd floor, Satna
485001 (M.P)

CONSULTANTS NAME & ADDRESS :

Rarwarbegpur, Post Kanakpur, Near Pindra Railway Station, Varanasi-210655
Ph:9899328602, 9997591118,
vva.global@gmail.com


ARCHITECT: Ar. Rahul Chaudhary
NORTH:

DRAWING TITLE : ELECTRICAL - SWITCH AND POWER POINT LOCATION LAYOUT PLAN
SHEET No 1/1

DEALT : Er. Sanjay Verma
CHECKED : Ar. Manoj Kumar

SCALE : 1:60
DATE : 02Dec. 2024

DRAWING NO. : VA/BANK/INDB/TKMGRH/LP
OPTION/ REVISION 0P-00/R-00

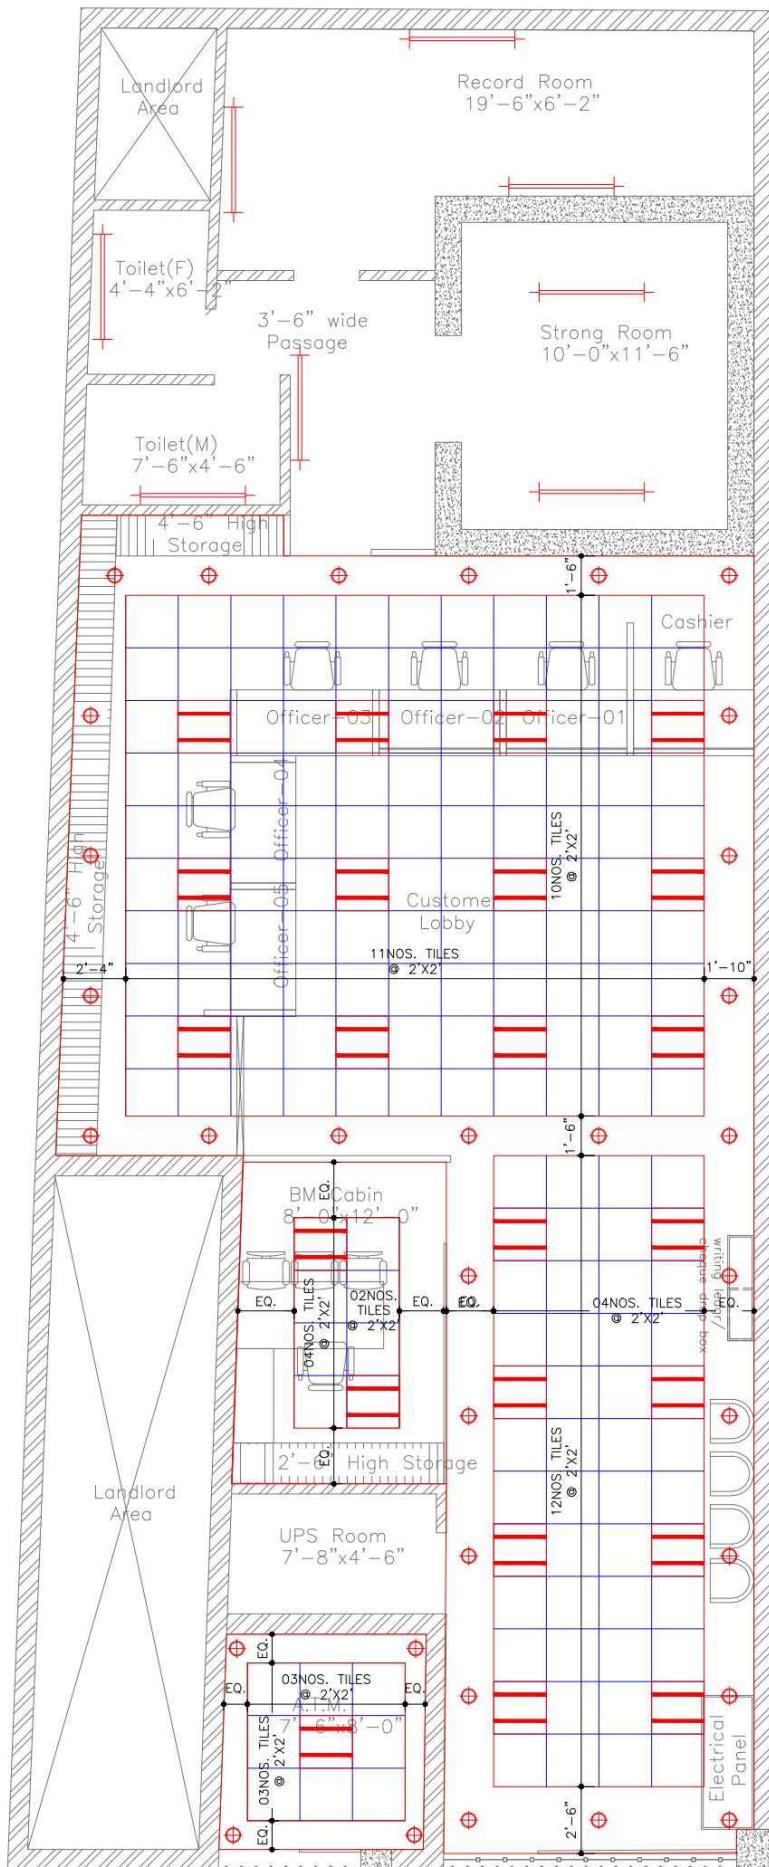

ELECTRICAL LEGENDS

SN.	DESCRIPTIONS	SYM	HGT
1.	WALL FAN		6'-6"
2.	CEILING LIGHT (2X18W)		CEILING
3.	CEILING LIGHT (1X18W)		CEILING
4.	EXHAUST FAN(CEILING)		CEILING
5.	SWITCH BOARD		4'-0"
6.	15A POWER POINT		1'-0"
7.	SDB		4'-0"
8.	PDB		4'-0"
9.	COMPUTER POINT		SEE BELOW
10.	TELEPHONE POINT		SEE BELOW
11.	2NOS. 5A SOCKET WITH 15A SWITCH		SEE BELOW
12.	RAW POWER		SEE BELOW
13.	5A SOCKET		3'-6"
14.	AC POINT		7'-0"
15.	UPSDB		4'-0"
16.	15A SOCKET		3'-6"
17.	WALL BRACKET		7'-0"
18.	2x36W CEILING LIGHT		CEILING

- 3 NOS 5 A SOCKET (150 MM BELOW DESK TOP) WITH 15A SWITCH (150 MM ABOVE DESK TOP)
- 5 A SWITCH SOCKET FOR RAW (150 MM ABOVE DESK TOP)
- 1 NO. DATA (150MM BELOW DESK TOP)
- 1NO. VOICE (150MM ABOVE DESK TOP)
- 15 A SWITCH SOCKET FOR RAW (150 MM BELOW DESK TOP)

ELECTRICAL LEGENDS

DESCRIPTIONS	SYM	HGT
WALL FAN		6'-6"
TUBE LIGHT (LED)		8'-0"/ ceiling
2'-0" X 2'-0" LIGHT (LED)		ceiling
CEILING FAN		ceiling
15 W DOWN LIGHTER (LED)		ceiling
AC POINTS		7'-0"
EXHAUST FAN		7'-0"
CASSETTE AC		ceiling

	2X2' GRID CEILING	GRID CEILING
	2X2' 36 WT GRID LIGHT	ON CEILING
	18W BLAIRE RECESSED LED DOWN LIGHT.	ON CEILING
	18W LIGHT UP DOWN LINEAR RECESSED LED LIGHT	ON CEILING

PROJECT NAME:
PROPOSED INTERIOR FURNISHING LAYOUT FOR INDIAN BANK TIKAMGARH BRANCH (M.P)

CLIENT NAME & ADDRESS :



Indian Bank


Zonal Office, Satna
Jai Stambh Chowk, 2nd floor, Satna
485001 (M.P)

CONSULTANTS NAME & ADDRESS :



Vaastu Vikalp Architects

Rarwarbegpur, Post Kanakpur, Near Pindra Railway Station, Varanasi-210655
Ph:9899328602, 9997591118, vva.global@gmail.com


ARCHITECT: Ar. Rahul Chaudhary	NORTH: 
--	--

DRAWING TITLE : FALSE CILING LAYOUT PLAN	SHEET No 1 1
--	---------------------------

DEALT : Er. Sanjay Verma	CHECKED : Ar. Manoj Kumar
------------------------------------	-------------------------------------

SCALE : 1:60	DATE : 02Dec. 2024
------------------------	------------------------------

DRAWING NO. : VA/BANK/INDB/TKMGRH/LP	OPTION/ REVISION 0P-00/R-00
--	---------------------------------------

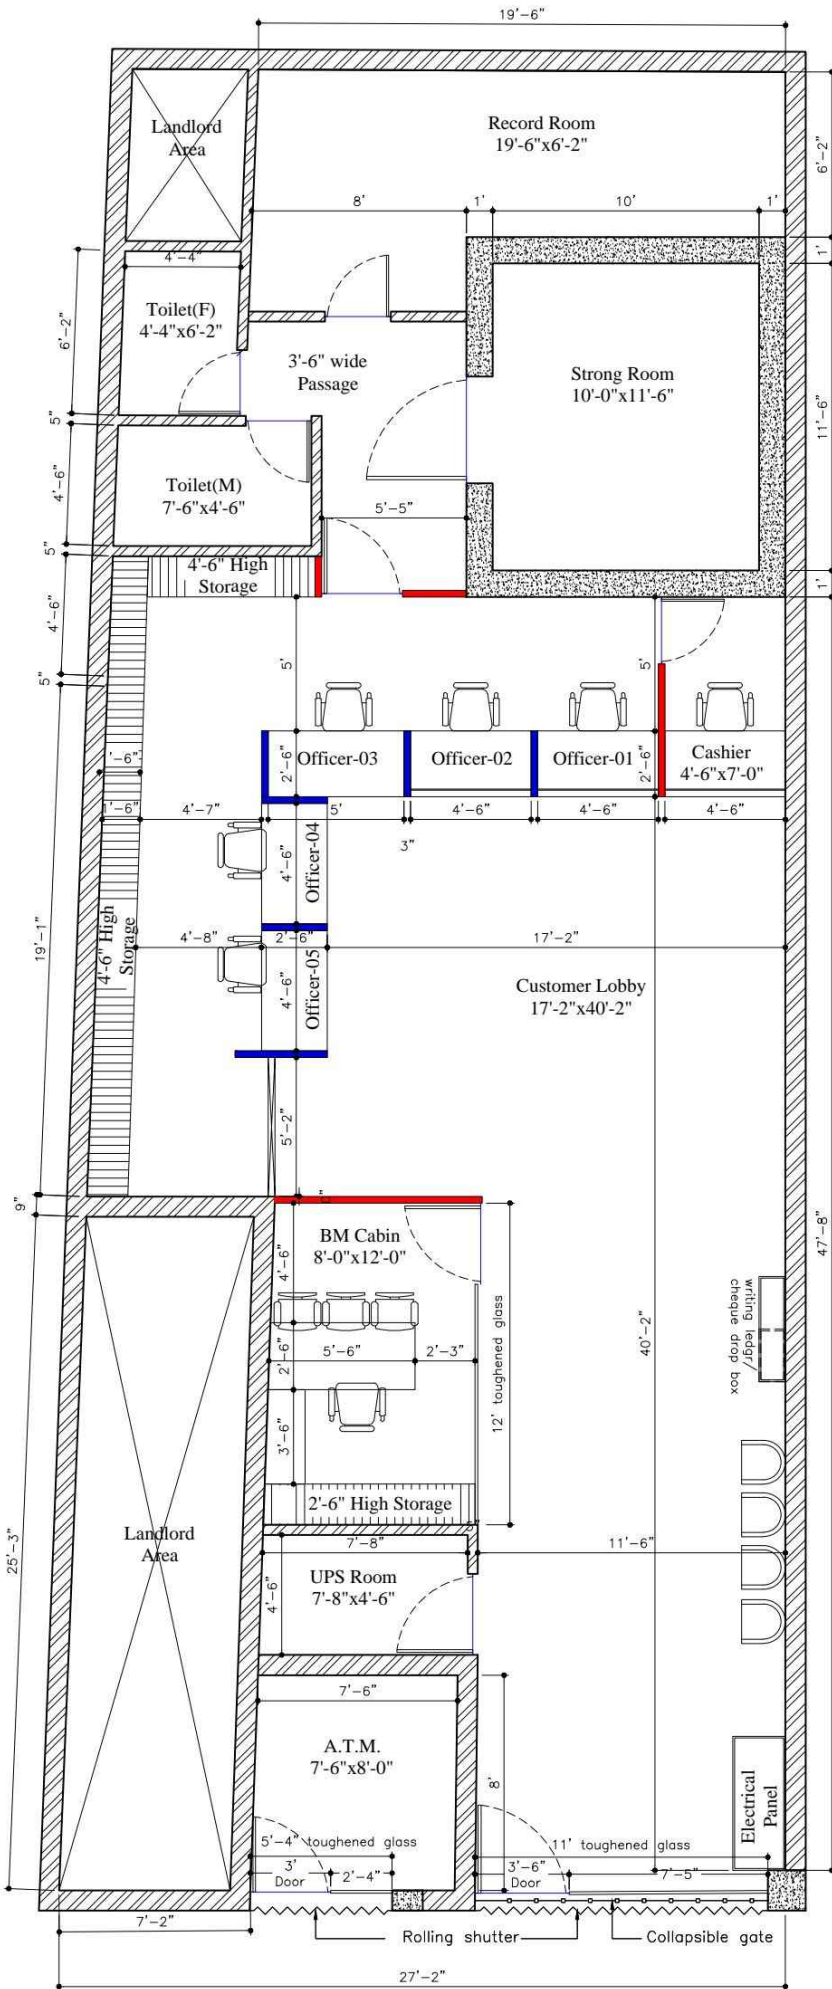

8'-6" high partition



4'-6" high partition

AREA STATEMENT	AREA
STRONG ROOM CARPET AREA	115.00 sq.ft.
UPS ROOM CARPET AREA	34.52 sq.ft.
A.T.M. CARPET AREA	60.00 sq.ft.
RECORD ROOM CARPET AREA	140.47 sq.ft.
BRANCH HALL CARPET AREA	1057.54 sq.ft.
BRANCH HALL CARPET AREA	1407.53 sq.ft.
TOILET AREA	60.48 sq.ft.

PROJECT NAME:
PROPOSED INTERIOR FURNISHING LAYOUT FOR
INDIAN BANK TIKAMGARH BRANCH (M.P)

CLIENT NAME & ADDRESS :



Zonal Office, Satna
Jai Stambh Chowk, 2nd floor, Satna
485001 (M.P)

CONSULTANTS NAME & ADDRESS :



Rarwarbegpur, Post Kanakpur, Near
Pindra Railway Station, Varanasi-210655
Ph:9899328602, 9997591118,
vva.global@gmail.com

ARCHITECT:
Ar. Rahul Chaudhary



DRAWING TITLE :
PROPOSED LAYOUT PLAN

SHEET No
1
1

DEALT :
Er. Sanjay Verma

CHECKED :
Ar. Manoj Kumar

SCALE :
1:60

DATE :
21 Nov. 2024

DRAWING NO. :
VA/BANK/INDB/TKMGRH/LP

OPTION/ REVISION
0P-00/R-00